


BUILDING LEGEND



| | | | | | |
|------------------------------------|----------------------------------|---------------------------------------|--|--|---|
| 1 CRARY SCIENCE AND ENG CENTER | 37 PUMP HOUSE (HELO PAD) | 108 GALLAGHER'S CLUB | 136C MODULAR OFFICE | 157 COLD STORAGE WAREHOUSE | 175 FEMC/IT/NSF OFFICE |
| 2 CSEC EMERGENCY GENSET | 39 SHIP OFF LOAD COMMAND CENTER | 115 ICE PIER | 137 NSF BERTHING | 159 FM/AGE/COMMS WAREHOUSE | 176 COLD FOOD STORAGE |
| 3 CORE STORAGE | 67 IMP-8 ANTENNA SHELTER | 120 INFOSYS/FOOD WAREHOUSE | 140 MCC/POST OFFICE/CENTRAL SUPPLY | 160 BERG FIELD CENTER | 177 PAINT BARN/STORAGE |
| 4 SCIENCE SUPPORT CENTER PHASE I | 68 PORTACOM | 121 ELECTRICAL WHSE (CMO BEER & SODA) | 141 FUEL DEPARTMENT OFFICE/SHOP | 161 CARPENTRY SHOP (TOW-AWAY) | 179 SEA WATER INTAKE |
| 7 CHAPEL OF THE SNOWS | 72 OIL SEPARATOR BUILDING | 122 SKUA CENTRAL | 142 MAC MEDICAL DISPENSARY | 162 BFC FREEZER (WALK-IN) | 182 FIRE HOUSE/TELEPHONE EXCHANGE |
| 10 HUT TEN | 73 CARGO WAREHOUSE/BFC FOOD ROOM | 124 SEAWATER INTAKE PUMP HOUSE | 143 HEAVY VEHICLE MAINTENANCE FACILITY | 164 FROZEN FOOD STORAGE | 183 TEMPORARY AIR DROP FACILITY |
| 16 MCMURDO RF SHELTER (BEHIND BFC) | 75 GYM | 125 NSF BERTHING | 144 DIVE SHACK | 165 MCMURDO OPERATIONS/AIR TRAFFIC/WEATHER | 185 WASTE MANAGEMENT |
| 17 EQUIPMENT OPERATIONS | 76 COFFEE HOUSE | 129 HELICOPTER HANGAR | 146 GRAVITY BASE STATION 2 | 166 NSF BERTHING (HOTEL CALIFORNIA) | 188 NSF BERTHING (MAMMOTH MOUNTAIN INN) |
| 33 REUSE/RESALE OFFICE | 78 AEROBICS FACILITY | 132 SUPPLY WAREHOUSE (GSK AUTOMOTIVE) | 150 FUEL PUMP HOUSE | 167 CHALET - NATIONAL SCIENCE FOUNDATION | 189 JOINT SPACECRAFT OPERATION CENTER (JSOC) |
| 34 WARM-UP SHACK | 85 RECOMPRESSION CHAMBER | 136 FEMC TRADE SHOP | 151 FIRE PUMP HOUSE (BERTHING) | 168 AUTO UNHEATED STORAGE WAREHOUSE | 191 LOGISTICS/MATERIALS/MAPCON |
| 35 WARM-UP SHACK | 90 TRUCK SCALE | 136A MODULAR OFFICE | 155 GALLEY/BERTH/STORE/LAUNDRY/LIBRARY | 170 HAZARDOUS WASTE FACILITY | 191 RESTROOM MODULE |
| 36 HELO PAX TERMINAL | 107 SOUTHERN EXPOSURE | 136B MODULAR OFFICE | 156 AIR GUARD SUPPLY WAREHOUSE | 174 FLAMMABLE STORAGE WAREHOUSE | 191A CARPENTRY WORKSHOP/TOOL ROOM |
| | | | | | 191B MODULAR OFFICE |
| | | | | | 191C MODULAR OFFICE |
| | | | | | 192 SAFETY/QUALITY ASSURANCE |
| | | | | | 193 USAP CARGO OFFICE |
| | | | | | 196 POWER PLANT |
| | | | | | 198 WATER DISTILLATION PLANT |
| | | | | | 199 WASTE WATER TREATMENT PLANT |
| | | | | | 200 LIFT STATION/WASTE WATER TREATMENT PLANT |
| | | | | | 201 BERTHING |
| | | | | | 202 BERTHING |
| | | | | | 203A BERTHING |
| | | | | | 203B BERTHING |
| | | | | | 203C BERTHING |
| | | | | | 206 BERTHING |
| | | | | | 207 BERTHING |
| | | | | | 208 BERTHING |
| | | | | | 209 BERTHING |
| | | | | | 210 BERTHING |
| | | | | | 211 BERTHING |
| | | | | | 340 UNHEATED STORAGE |
| | | | | | 341 UNHEATED STORAGE |
| | | | | | 341A COLD STORAGE ANNEX |
| | | | | | 342 UNHEATED STORAGE |
| | | | | | 344 UNHEATED STORAGE (CONVERTED D3 FUEL TANK) |
| | | | | | 345 UNHEATED STORAGE (CONVERTED D4 FUEL TANK) |
| | | | | | 347 UNHEATED STORAGE (CONVERTED J3 FUEL TANK) |
| | | | | | 348 D-2 PUMP HOUSE |
| | | | | | 349 MOGAS ENCLOSURE |
| | | | | | 637 CONSTRUCTION STORAGE WAREHOUSE JAMESWAY |
| | | | | | 700 SMOKING SHELTER |
| | | | | | 701 SMOKING SHELTER |
| | | | | | 702 SMOKING SHELTER |

TANK LEGEND

| |
|---------------------|
| D2 DIESEL TANK |
| D12 DIESEL TANK |
| D13 DIESEL TANK |
| D15 BULK FUELS TANK |
| J5 JET FUEL TANK |
| J6 JET FUEL TANK |
| J7 JET FUEL TANK |
| J8 JET FUEL TANK |
| J9 JET FUEL TANK |
| M1 MOGAS TANK |
| M3 MOGAS TANK |
| M4 MOGAS TANK |
| M5 MOGAS TANK |
| M6 MOGAS TANK |
| T1 REDUNDANT TANK |

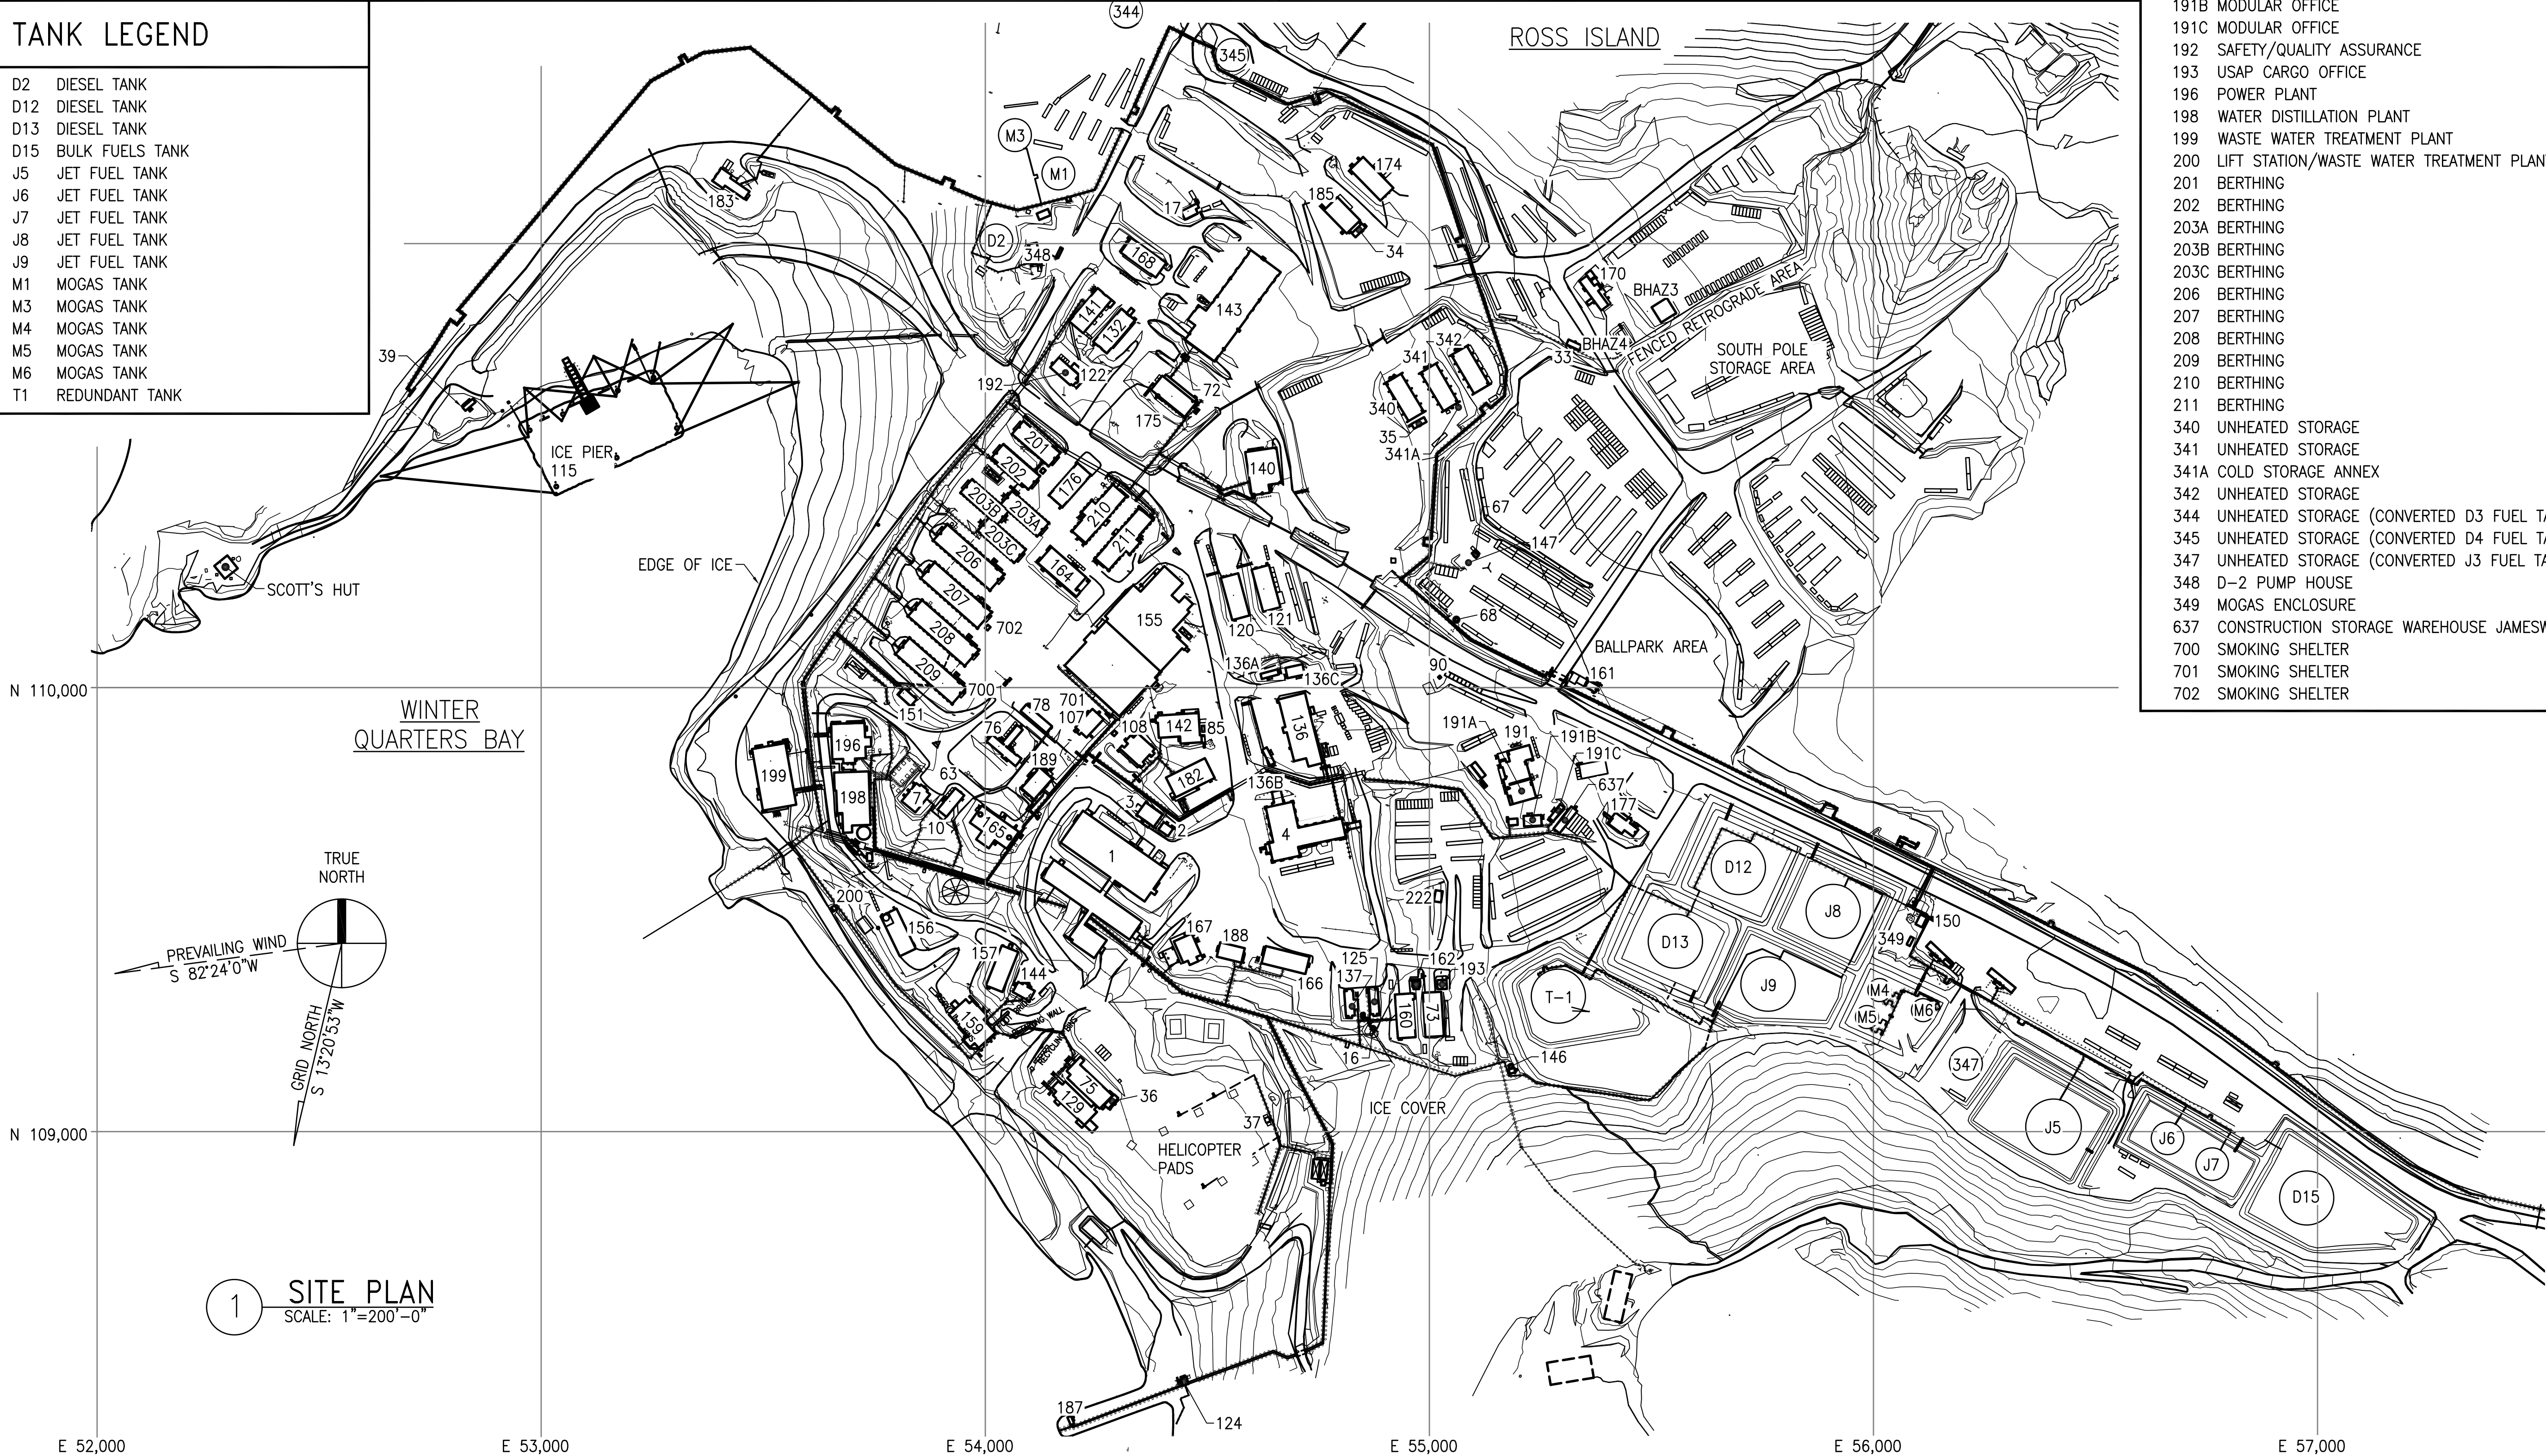

1 SITE PLAN
SCALE: 1"=200'-0"

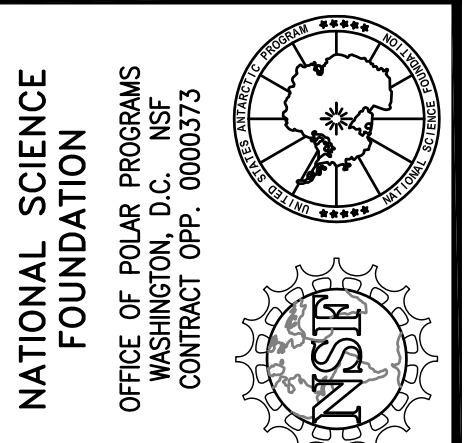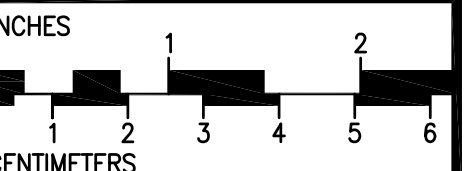

REVISION LOG

| REV. | DATE | DESCRIPTION | DFTG. | APPD. |
|------|------------|--------------------|-------|-------|
| 5 | 7/02/2014 | 2013-2014 AS-BUILT | MUL | JH |
| 4 | 10/28/2010 | 2009-2010 AS-BUILT | RJT | CP |
| 3 | 2/18/2010 | 2008-2009 AS-BUILT | RJT | CP |
| 2 | 2/18/2010 | 2007-2008 AS-BUILT | RJT | CP |
| 1 | 3/26/2008 | 2006-2007 AS-BUILT | JH | CP |

MCMURDO STATION
STATION SITE PLANS
MASTER STATION AS-BUILTS
CIVIL / SURVEY

7400 South Tucson Way
Centennial, Colorado
80112-3938 USA
303-790-8606
800-688-8606

PROJECT NUMBER:

FILE NAME:
MCMSSPC-104-R5

DESIGNED BY: C. PALMER

DRAWN BY: R. TURNER

DATE CREATED: 10/25/2007

SHEET TITLE:
McMURDO STATION
MASTER
SITE PLAN

SHEET NUMBER:
C-104